




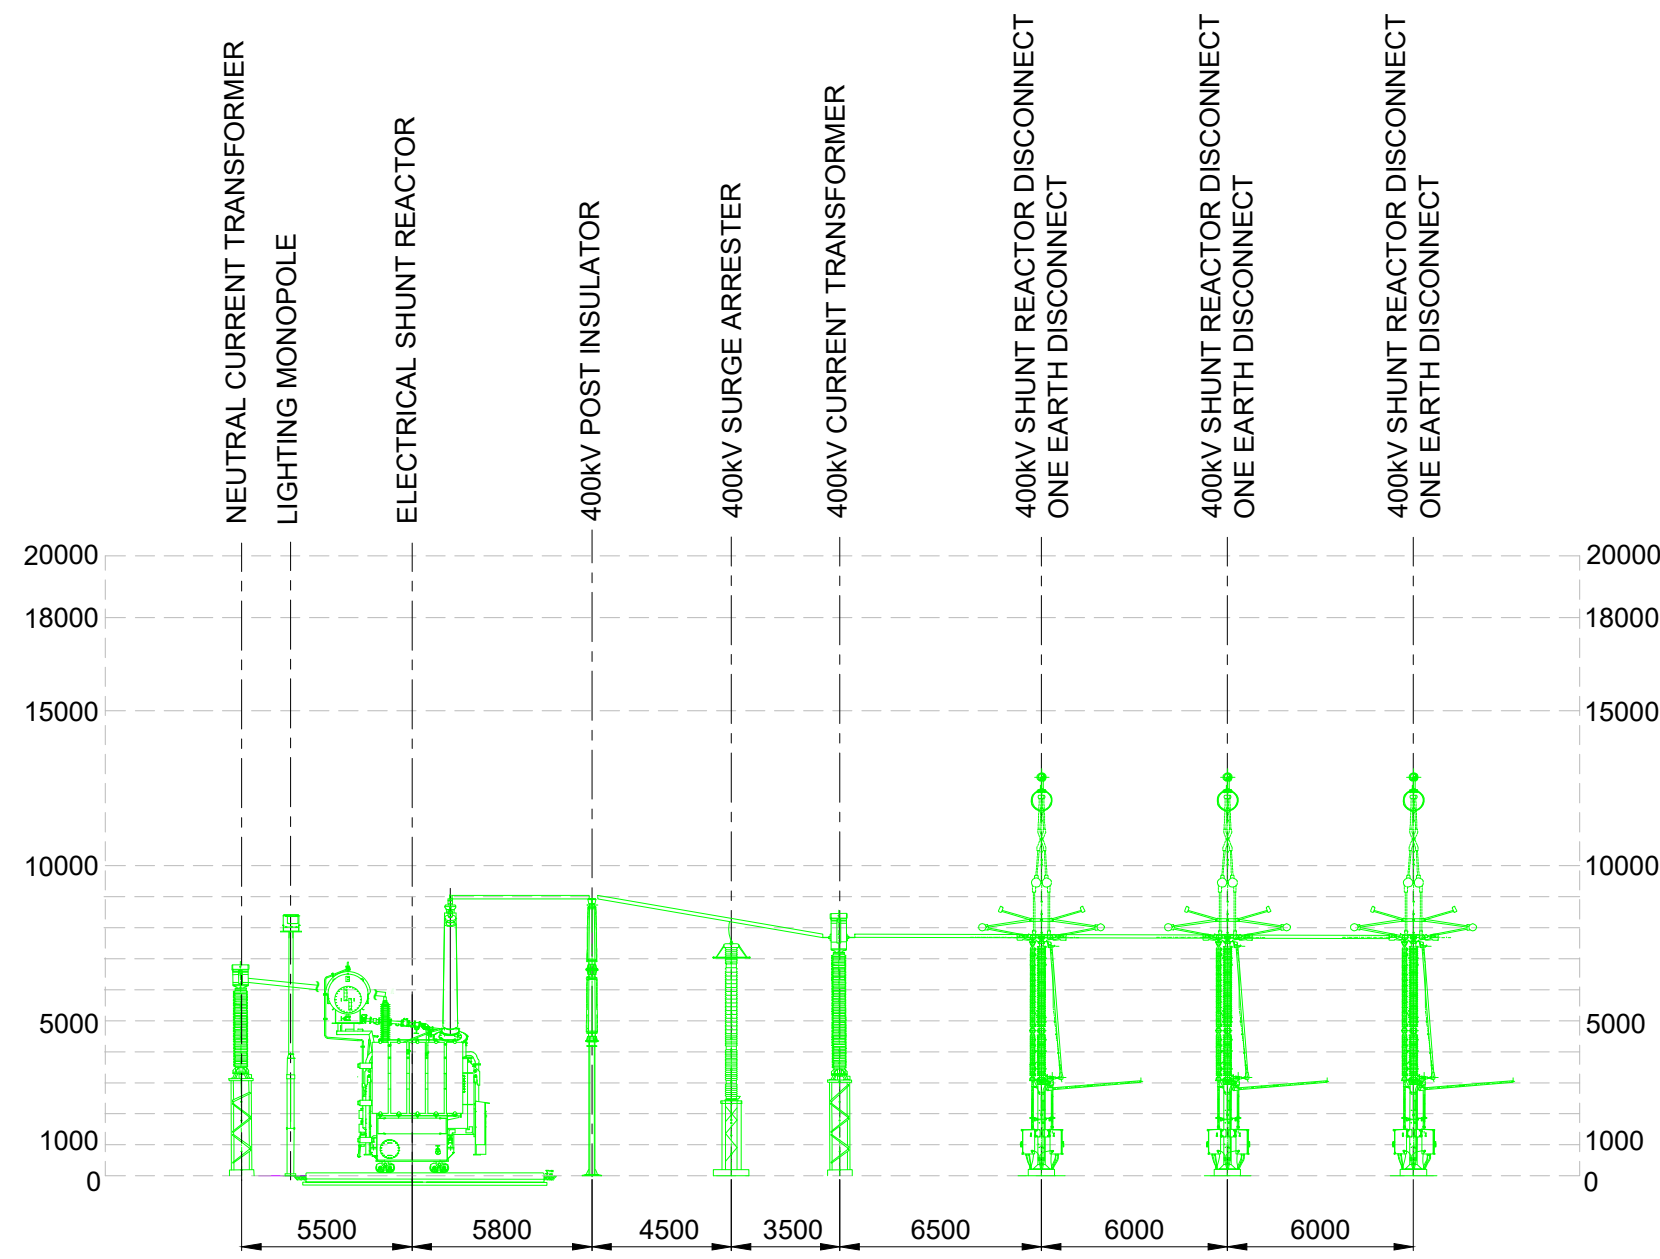


SECTION A-A
SCALE : 1:250

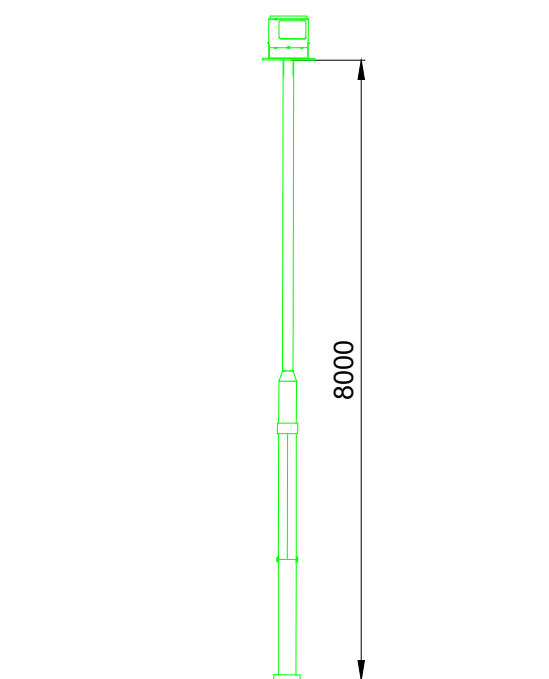

PROPOSED SECTION OF
NEW LIGHTING MONOPOLE
SCALE : 1:100

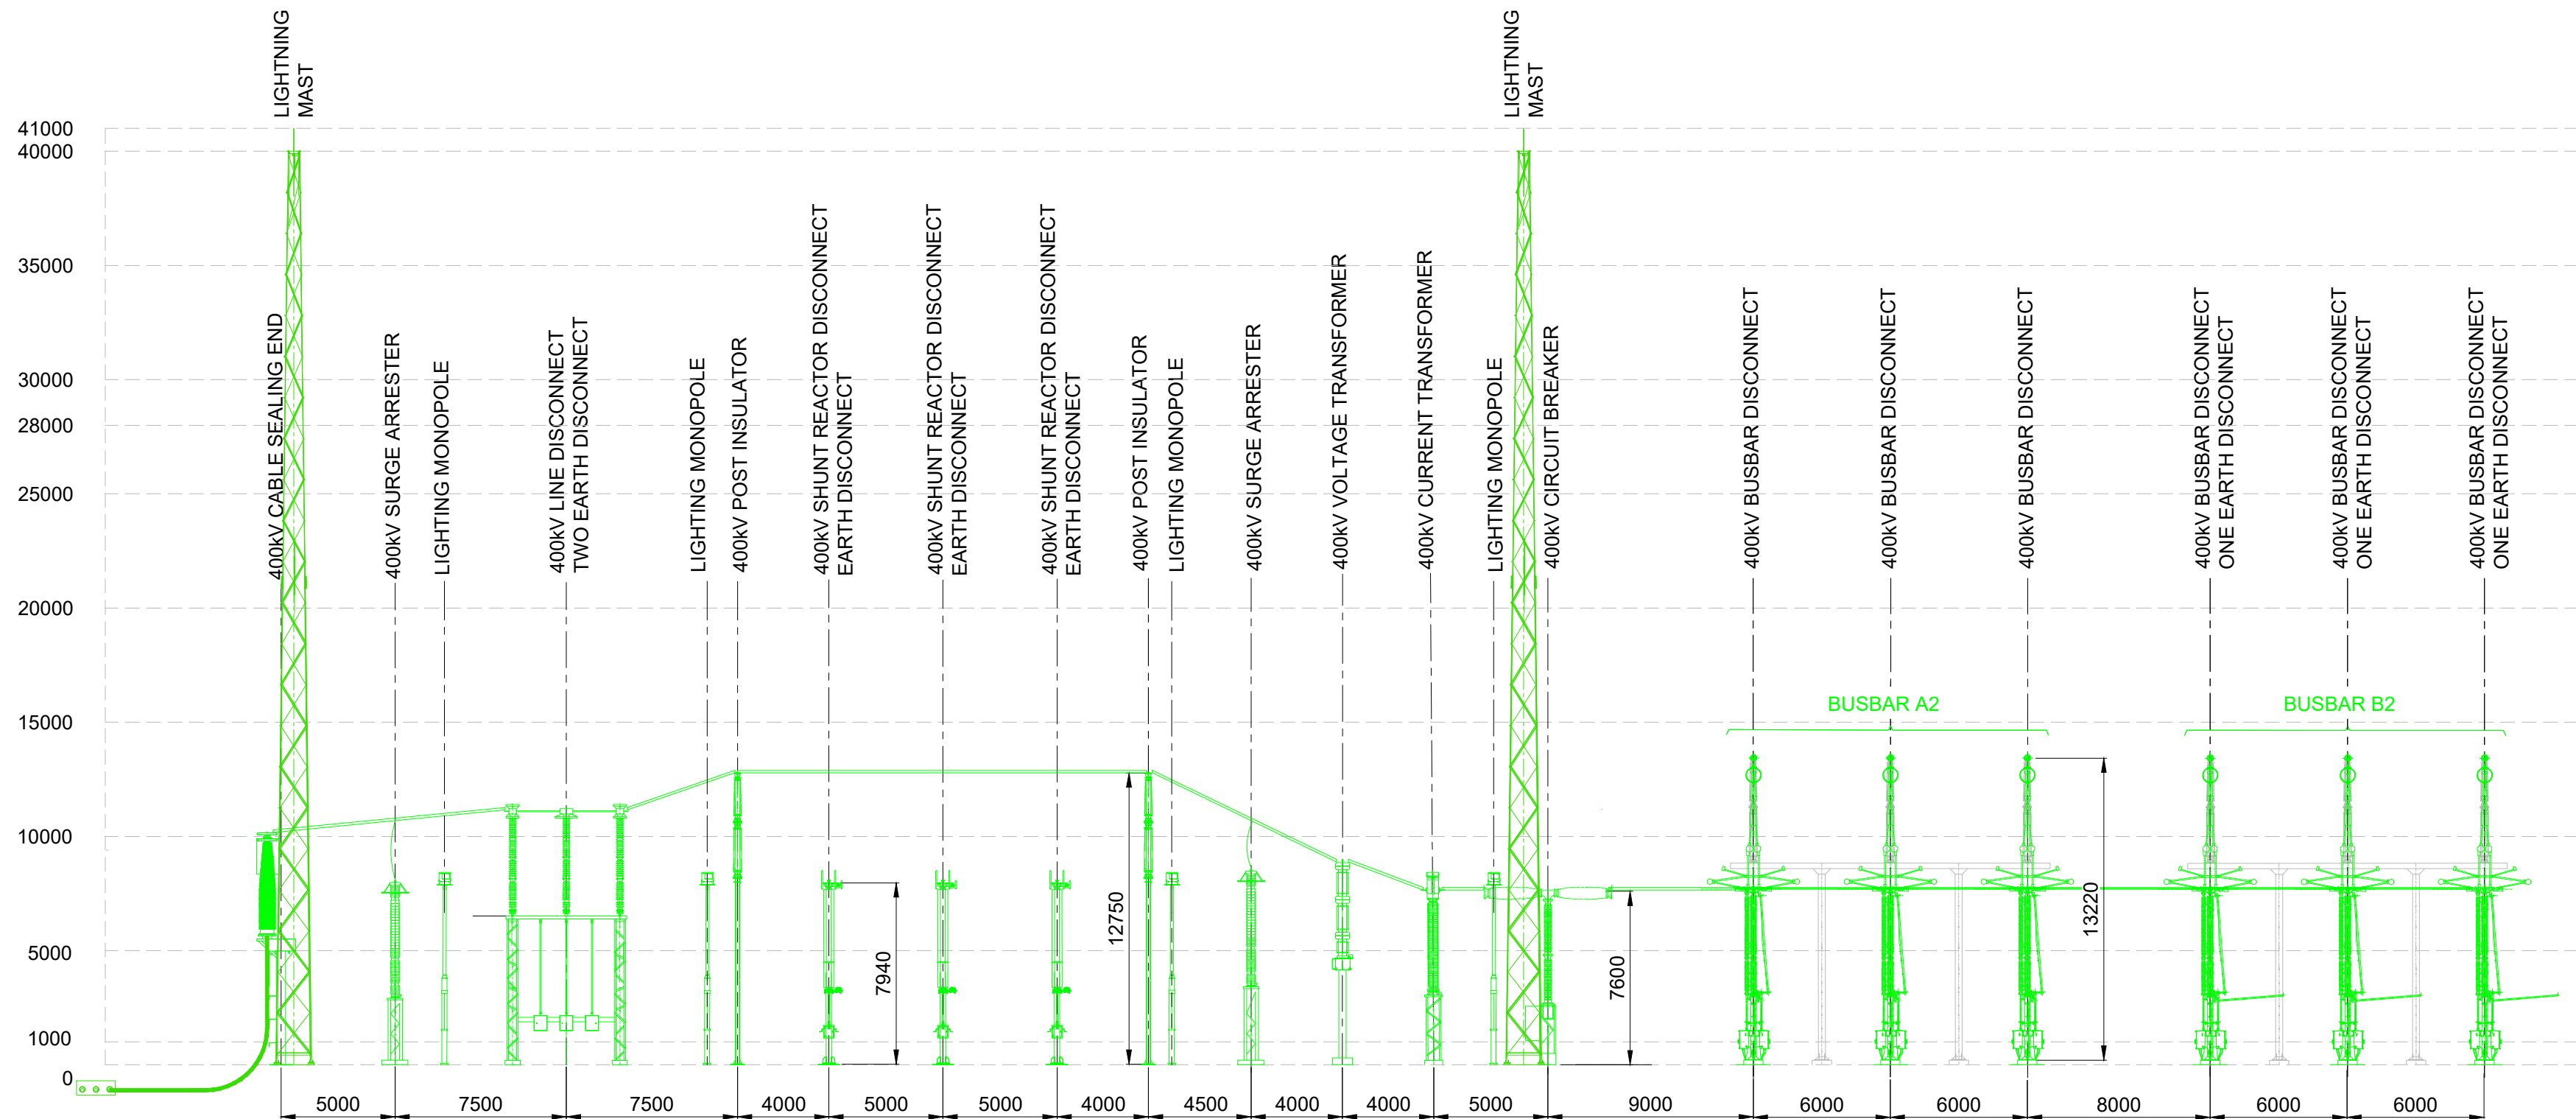

SECTION B-B
SCALE : 1:250

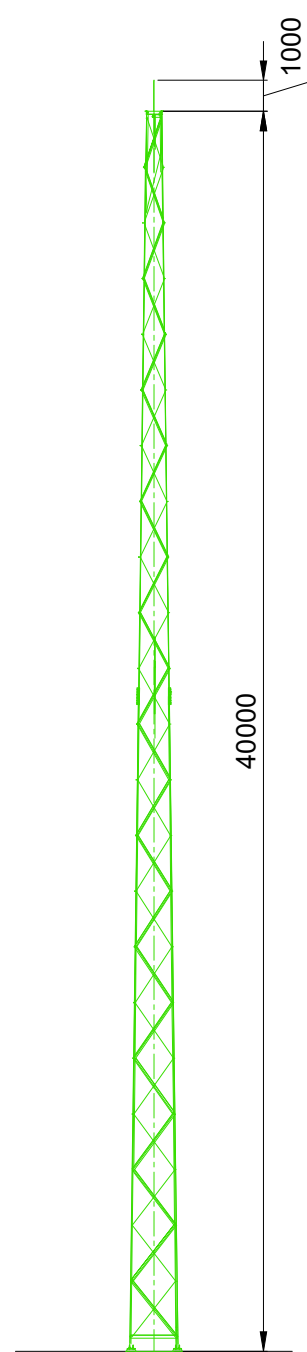

PROPOSED SECTION OF
NEW LIGHTNING MAST
SCALE : 1:250

NOTES

- All dimensions are in millimeters, unless otherwise noted.
- For planning purposes only, not for construction.
- The design is indicative and is subject to refinement at the detailed design stage.
- Where levels are shown, All levels are in Metres above malin head datum

REFERENCE

321084AH-JAC-ZZ-XX-DR-Z-1310 Dunstown 400kV Substation Site layout plan
321084AH-JAC-ZZ-XX-DR-Z-1311 Dunstown 400kV Substation Overall Site plan
321084AH-JAC-ZZ-XX-DR-Z-1312 Dunstown 400kV Substation Site plan
321084AH-JAC-ZZ-XX-DR-Z-1313 Dunstown 400kV Substation Site plan

LEGEND

— New Equipment

Jacobs

Merrion House, Merrion Road, Dublin, D04R2C5, Ireland
Phone: +353 (0)1 269 5666 Fax: +353 (0)1 269 5497
www.jacobs.com

Client



Project

KILDARE-MEATH GRID UPGRADE

Drawing title

**DUNSTOWN 400 kV SUBSTATION
SECTION ELEVATIONS**

Drawing status

FOR PLANNING

Suitability

S2

Scale

AS SHOWN@A1

DO NOT SCALE

Jacobs No.

321084AH

Client No.

CP966

Drawing number

321084AH-JAC-ZZ-XX-DR-Z-1340