
 


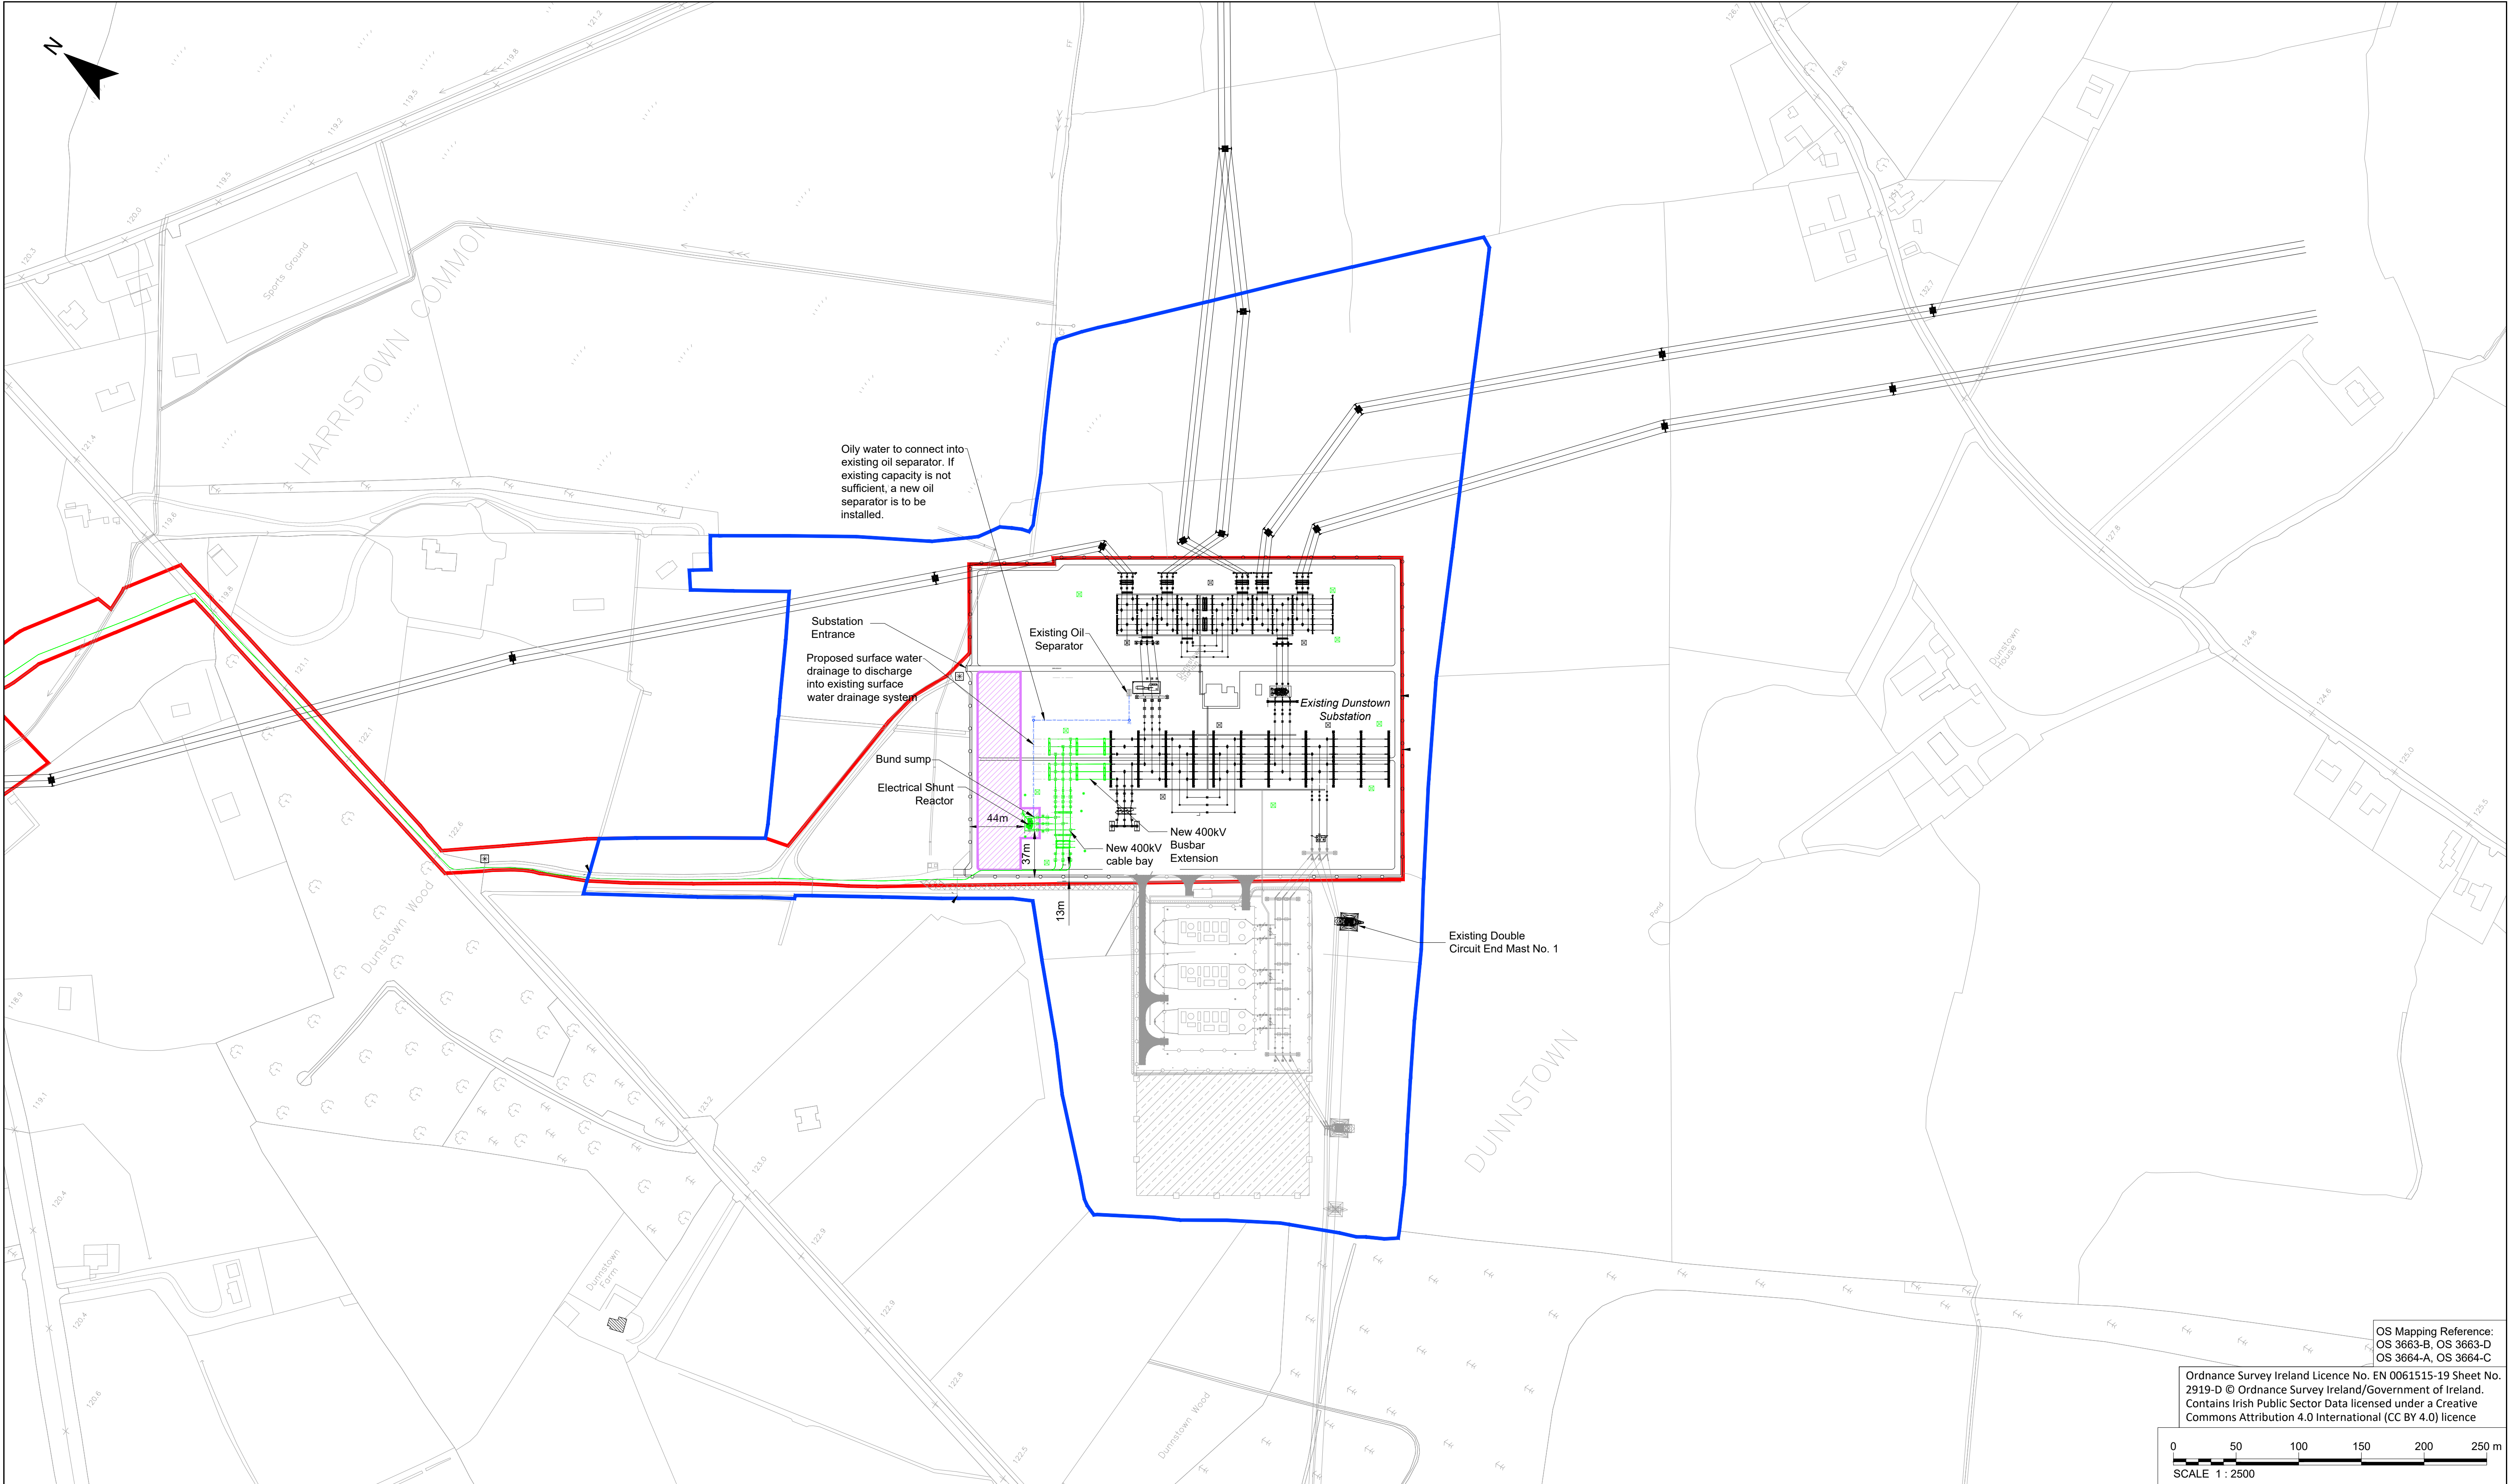

OS Mapping Reference:
OS 3663-B, OS 3663-D
OS 3664-A, OS 3664-C

Ordnance Survey Ireland Licence No. EN 0061515-19 Sheet No.
2919-D © Ordnance Survey Ireland/Government of Ireland.
Contains Irish Public Sector Data licensed under a Creative
Commons Attribution 4.0 International (CC BY 4.0) licence



NOTES

- All dimensions are in millimeters, unless otherwise noted.
- For planning purposes only, not for construction.
- The design is indicative and is subject to refinement at the detailed design stage.
- Where levels are shown, All levels are in Metres above main head datum

REFERENCE DRAWINGS

321084AH-JAC-ZZ-XX-DR-Z-1312 Dunstown 400kV Substation Site plan
321084AH-JAC-ZZ-XX-DR-Z-1340 Dunstown 400kV Substation Section Elevations.

LEGEND

- Planning application boundary
- ESB Landowner property boundary
- Existing Equipment
- Underground cable route / New equipment
- Development applied Dunstown Series Compensation under Kildare County Council ref. 211175 (Permission granted on 9th September 2022)
- Laydown Area
- Lightning mast
- Lighting monopole
- Site notice

- Proposed Oily Water Drainage
- CP Catch pit
- PC 1500e Penstock



KILDARE-MEATH GRID UPGRADE

DUNSTOWN 400 kV SUBSTATION SITE LAYOUT PLAN

Drawing status	FOR PLANNING		Suitability
Scale	1:2500@A1	DO NOT SCALE	S2
Jacobs No.	321084AH	Rev	
Client No.	CP966		

Drawing number
321084AH-JAC-ZZ-XX-DR-Z-1310